


**EXTERIOR LIGHTS:**

- |                                    |   |   |                                   |                     |
|------------------------------------|---|---|-----------------------------------|---------------------|
| <b>A</b><br>Wall Mounted<br>Sconce | <b>B</b><br>Surface mounted<br>pendant  | <b>C</b><br>Surface Mounted<br>Resident Light | <b>D</b><br>Wall Mounted<br>Light | <b>E</b><br>Bollard |
| <b>F</b><br>Ceiling<br>Downlight   | <b>G</b><br>Low Volt<br>Landscape Light | <b>H</b><br>Outdoor Street<br>Light           | <b>J</b><br>Ground Uplight        |                     |

**NOTES:**

1) SYMBOLS ARE INDICATIVE OF LIGHTING STYLE ONLY, AND ARE NOT INTENDED TO BE ILLUSTRATIVE OF THE FINAL FIXTURE SELECTION.

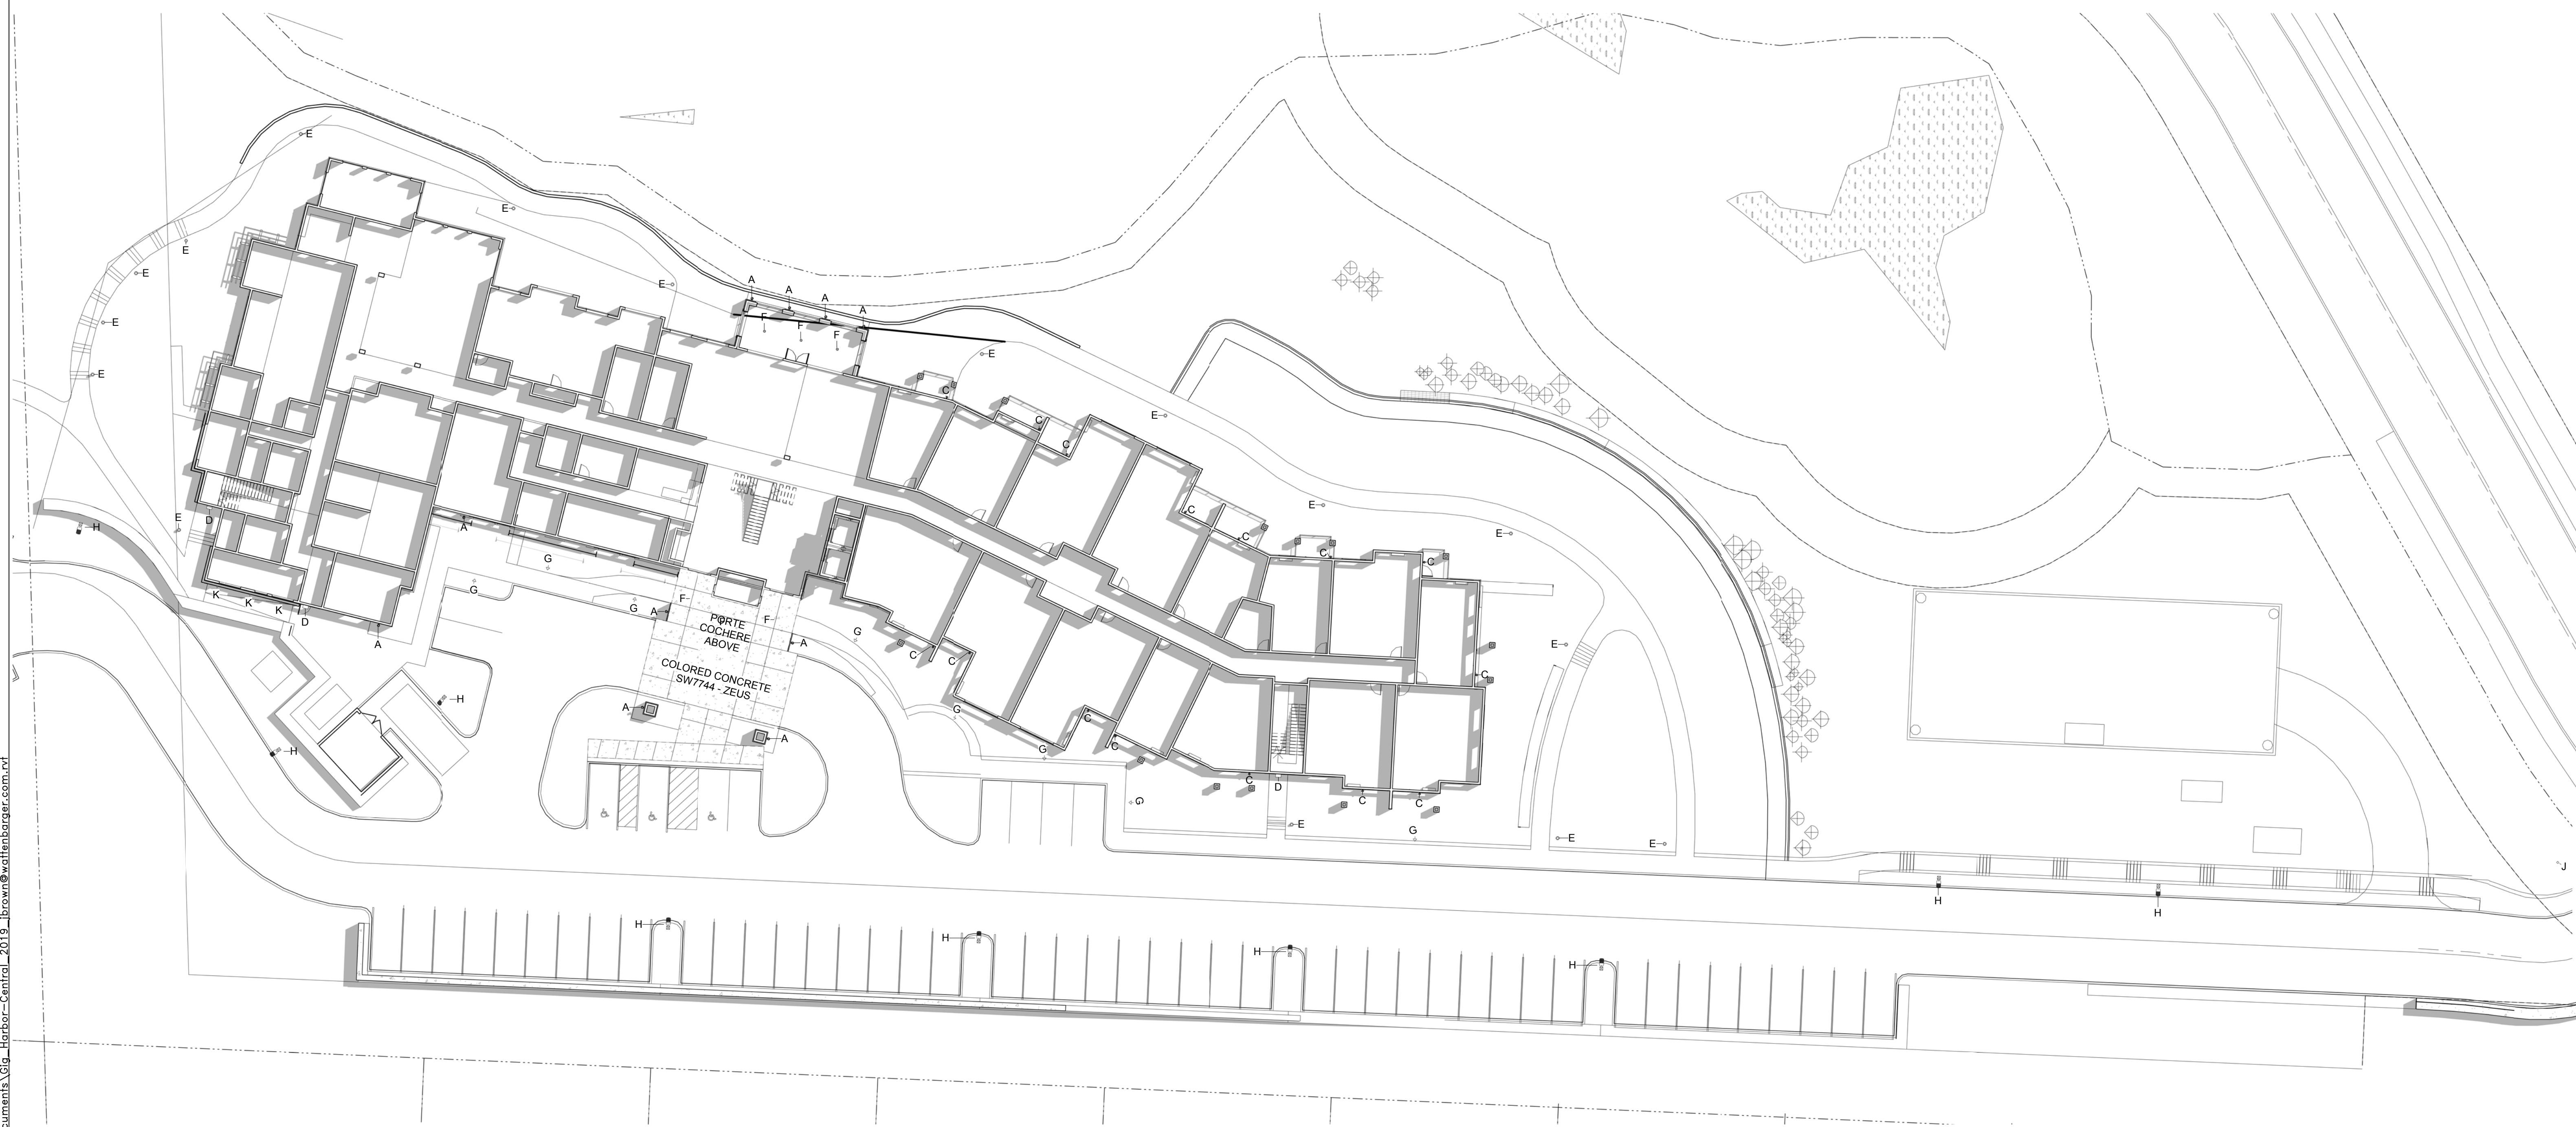

Revision Schedule	
#	DESCRIPTION

**LIGHTING PLAN**

**MALLARD'S LANDING LOT #7**  
 7100 BLOCK WAGNER WAY N.W.  
 RUSH DEVELOPMENT



JOB NO.: 21806  
 PLOT DATE: 1/6/2020 6:31:46 PM  
 DATE: 01/21/19  
 SCALE: As Indicated  
 DRAWN: DH  
 CHCKD: JB  
 SHEET NO.:

**A07**

